


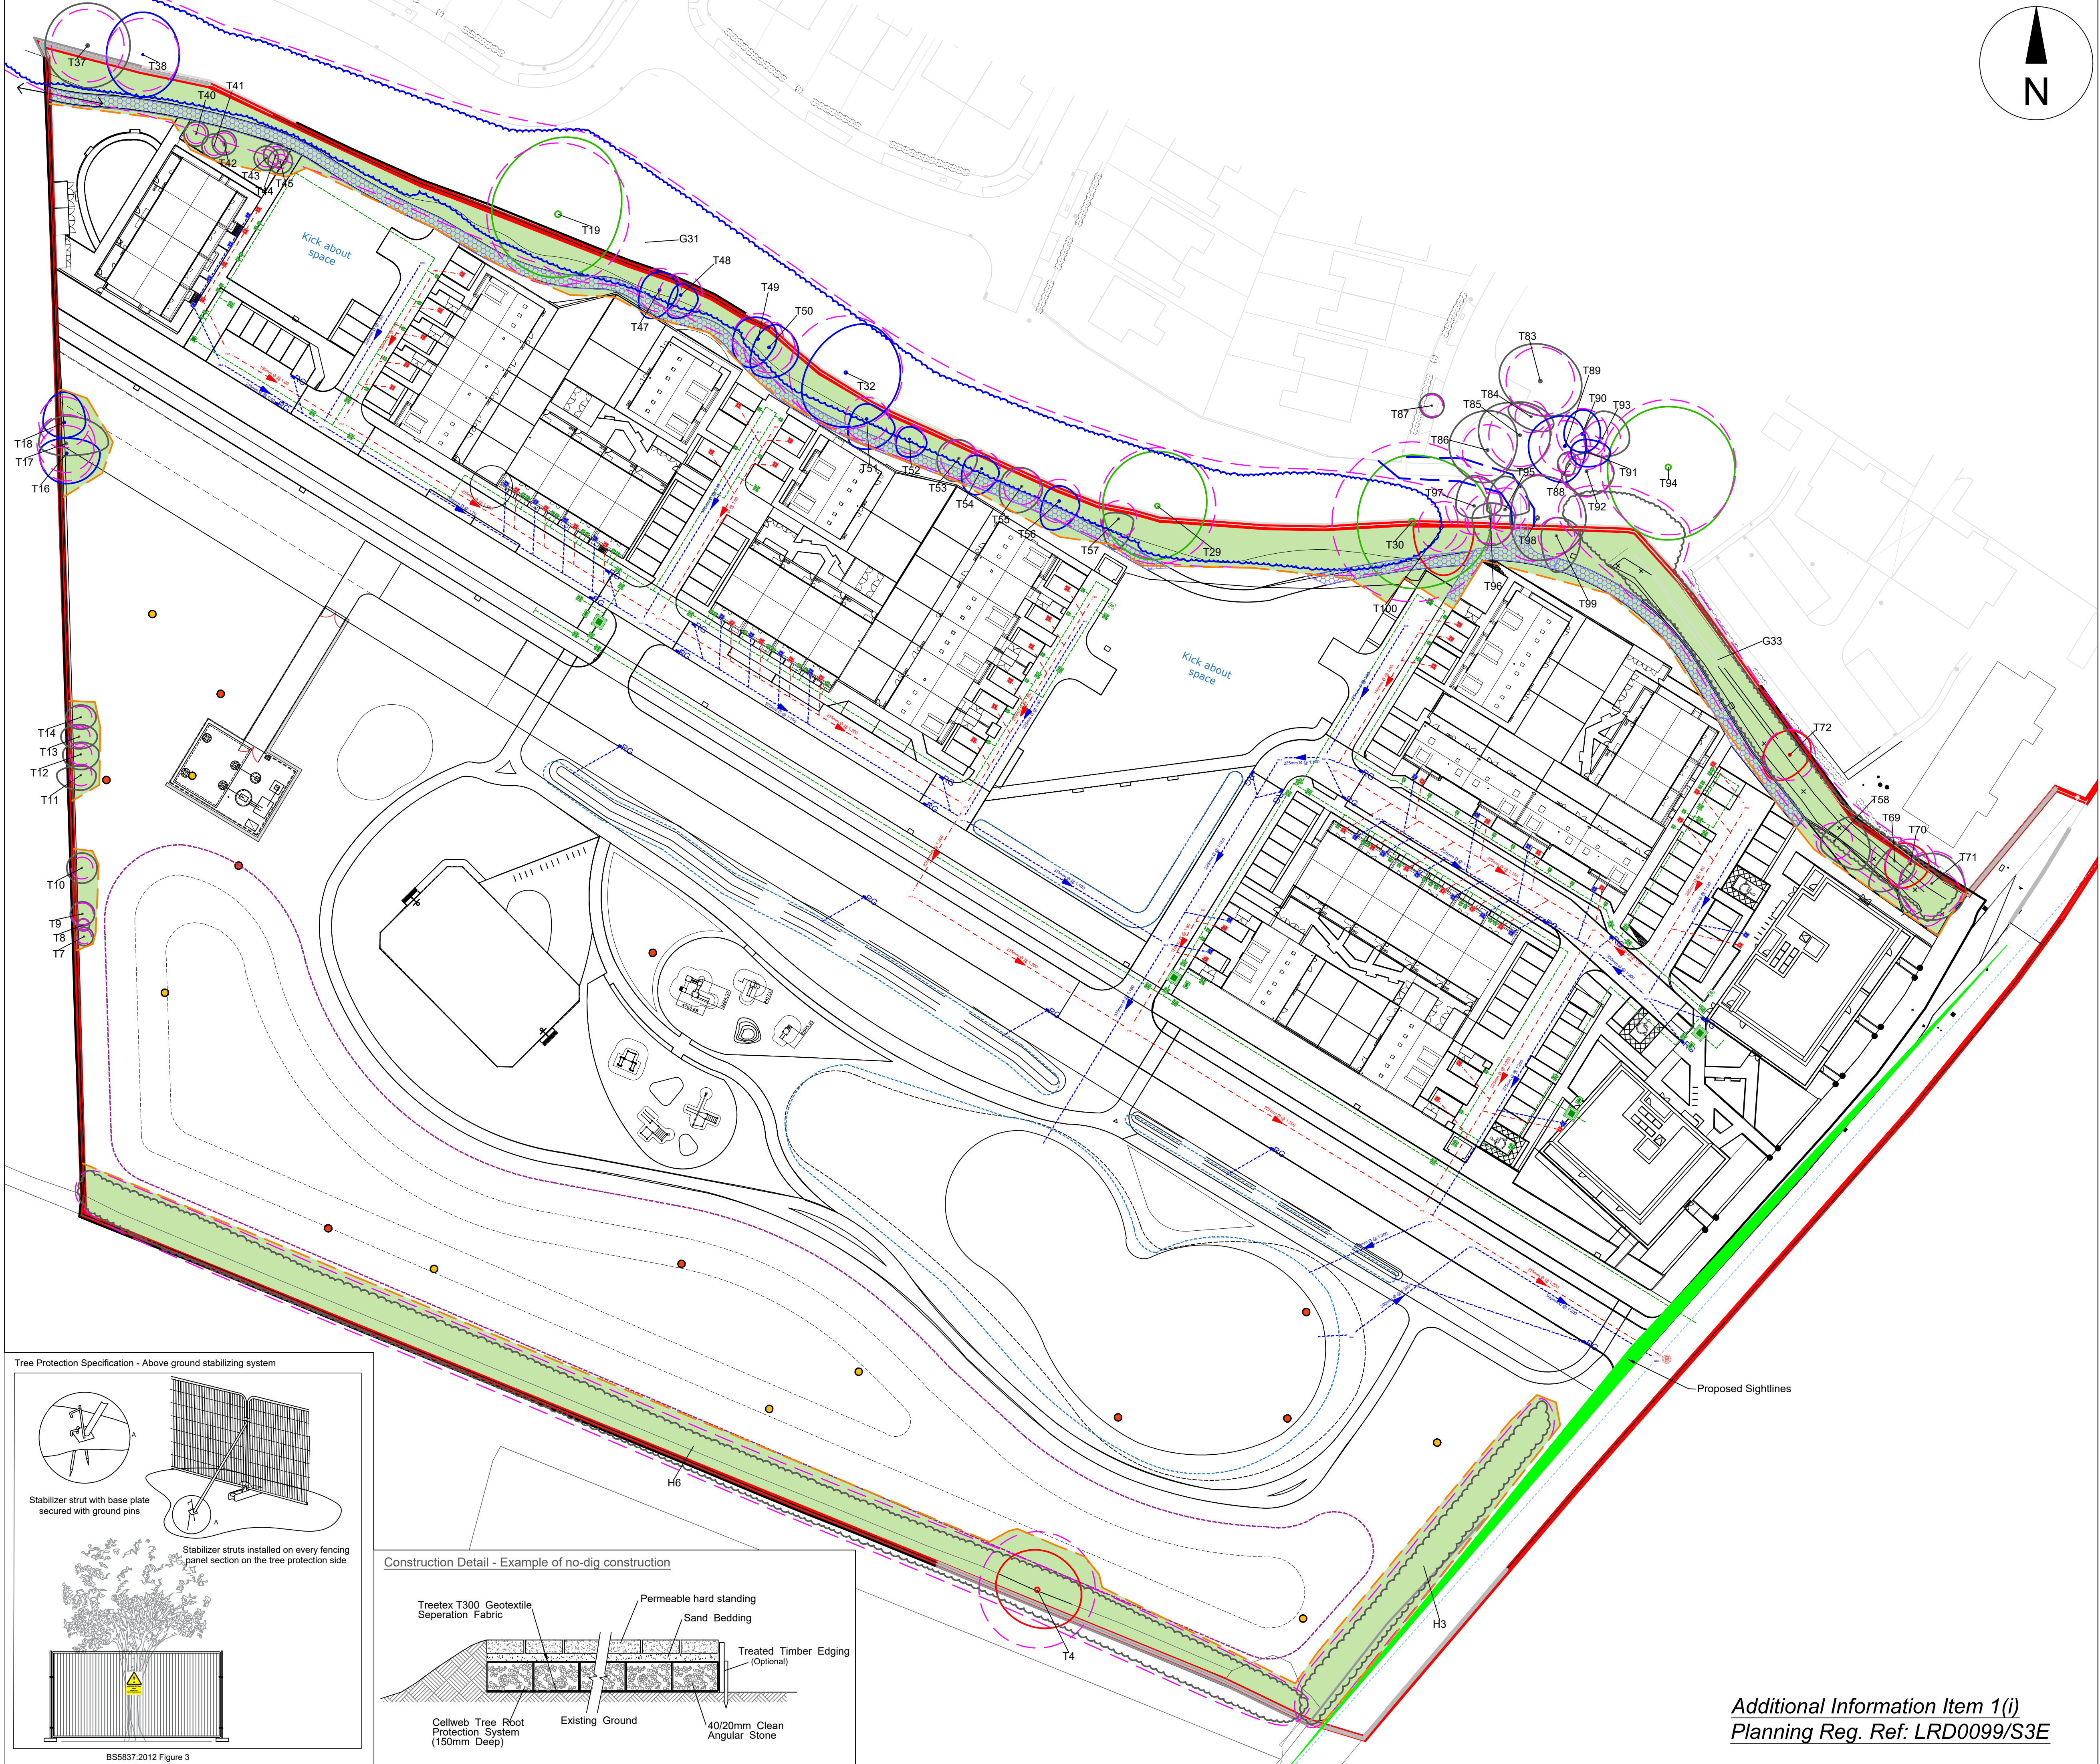

This drawing is to be read in conjunction with the respective arboricultural schedules and reports relevant to this project.

Where contradictions between this drawing and any other design information becomes apparent, the respective authors should be contacted immediately.

It is the responsibility of the main site contractor to check and verify all information and measurements onsite and confirm prior to the commencement of works, and to ensure that all site operatives work in accordance with respective arboricultural reports and BS5837:2012, Trees in relation to design, demolition and construction.

BS5837:2012 Tree Categorisation

	Category A Trees of high quality with an estimated remaining life expectancy of at least 40 years
	Category B Trees of moderate quality with an estimated life expectancy of at least 20 years
	Category C Trees of low quality with an estimated life expectancy of at least 10 years, or young trees with a stem diameter below 150mm
	Category U Those in such a condition that they cannot realistically be retained as living trees in the context of the current land use for longer than 10 years

Key

	Root Protection Areas The minimum area around a tree deemed to contain sufficient roots and rooting volume to maintain the trees viability.
	Tree, Shrub or Hedgerow Group.
T23	Reference Number for Tree, Group or Hedgerow.
	Site boundary.
	Tree Protection Zone - Protective fencing to be installed as per Specification. Designated Construction Exclusion Zone.
	No-dig construction requiring the installing of a cellular confinement system. Works carried out under arboricultural supervision.
	Temporary tree protection fence required during the construction of the footpath - Protective fencing to be installed as per specification
	Proposed site in BLACK
	Proposed drainage layout

Tree Protection Specification - Above ground stabilizing system

BS5837:2012 Figure 3

Construction Detail - Example of no-dig construction

Cellweb Tree Root Protection System (150mm Deep)

0 5m 10m 20m 30m 40m 50m

A	27/08/26	Updated plan fro RFI
Revision	Date	Description

Title:
Tree Protection Plan

Project:
Forest Road

Client:
Golden Port Homes Ltd.

Date:	25 Aug 2026	Scale:	1:500 @ A1	Status:	RFI Planning
Drawn by:	NAPB	Dwg ref:	240622-P-12	Rev:	A
Checked by:	CMcC				

This drawing is the copyright of CM Arbor Ltd. has been produced for the client and project as stated above. The drawing may not be reproduced or amended, except by the written permission of CM Arbor Ltd. No liability will be accepted for any amendments made by other persons. ©

CM Arbor Ltd.

Arboricultural Consultants

T: 085 843 7015 / E: charles@cmarbor.com / W: www.cmarbor.com

Additional Information Item 1(i)
Planning Reg. Ref: LRD0099/S3E